



HYDRANT SPACING (FROM PR. HYDRANT @ STA. 0+91):
 EAST - 260 LF TO EX. HYDRANT AT OSSIAN/LINCOLN
 WEST - 420 LF TO EX. HYDRANT ON OSSIAN (RT 36)

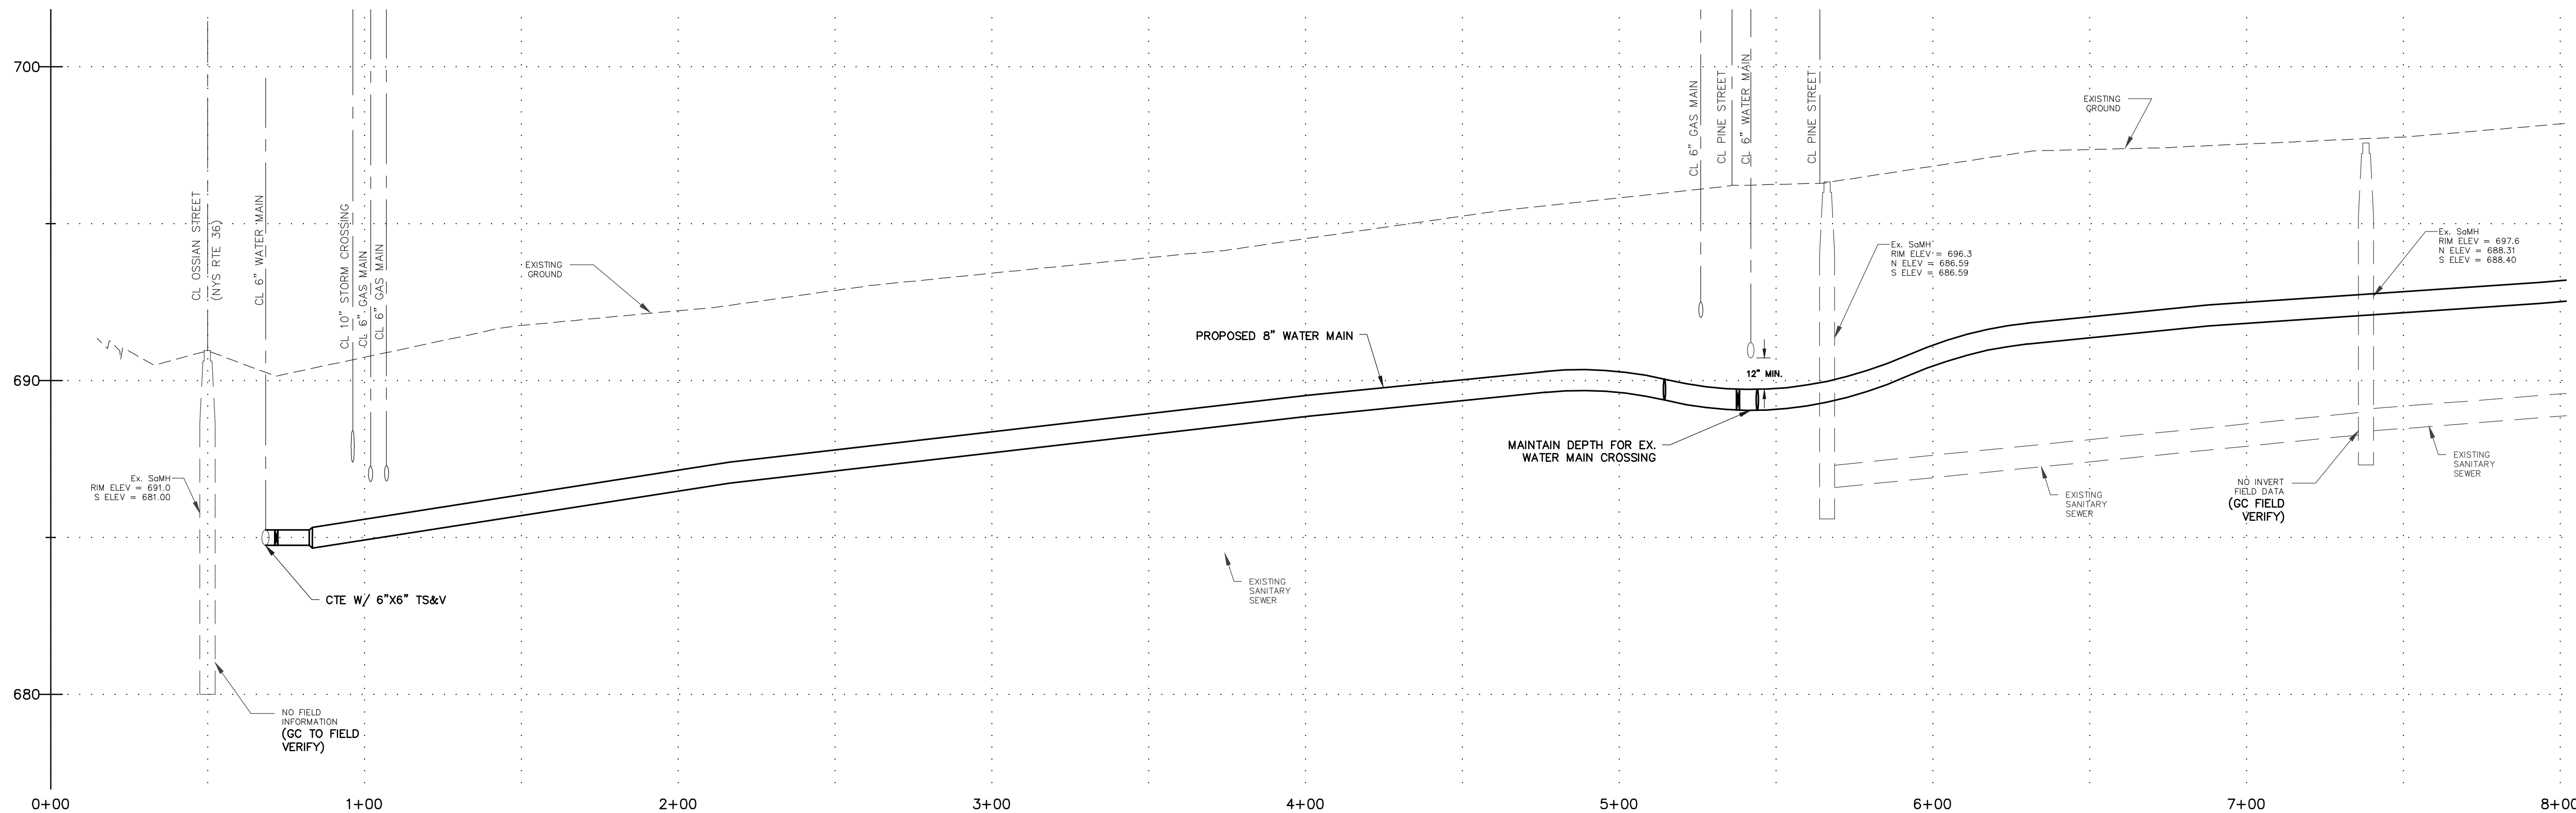

CENTERLINE WASHINGTON STREET
 HORIZ SCALE: 1" = 30'
 VERT SCALE: 1" = 3'

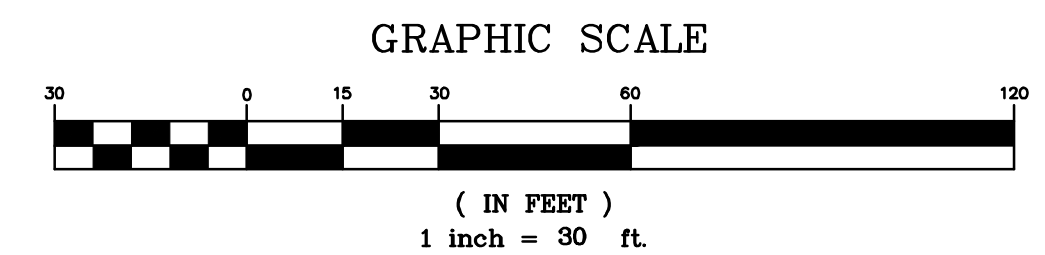

DRAWING ALTERATION
 THE FOLLOWING IS AN EXCERPT FROM THE NEW YORK EDUCATION LAW ARTICLE 145 SECTION 7209 AND APPLIES TO THIS DRAWING.
 "IT IS A VIOLATION OF THIS LAW FOR ANY PERSON UNLESS HE IS ACTING UNDER THE DIRECTION OF A LICENSED PROFESSIONAL ENGINEER OR LAND SURVEYOR TO ALTER AN ITEM
 IN ANY MANNER IF AN ITEM BEARING THE SEAL OF AN ENGINEER OR LAND SURVEYOR IS ALTERED. THE ALTERING ENGINEER OR LAND SURVEYOR SHALL AFFIX TO THE ITEM HIS SEAL
 AND THE NOTATION "ALTERED BY" FOLLOWED BY HIS SIGNATURE AND THE DATE OF SUCH ALTERATION AND A SPECIFIC DESCRIPTION OF THE ALTERATION."

AS ISSUED FOR PRELIMINARY REVIEW

Project Title:	VILLAGE WATER SYSTEM IMPROVEMENT PROJECT 2020 VILLAGE OF DANSVILLE LIVINGSTON COUNTY, NEW YORK	
Drawn By:	BJJ	
Checked By:	GJH	
Scale:	AS SHOWN	
Date:	1/2021	
Project No.:	0410.20002	
Sheet No.:	G-44	
of	TOT	
Project No.:	0410.20002	
ISSUED FOR NYSDOH REVIEW	By	Date
1.	DAH	4/29/21
Copyright © 2021 MRB Group All Rights Reserved		

Project Title: VILLAGE WATER SYSTEM
 IMPROVEMENT PROJECT 2020
 VILLAGE OF DANSVILLE
 LIVINGSTON COUNTY, NEW YORK

Drawn By: BJJ
 Checked By: GJH
 Scale: AS SHOWN
 Date: 1/2021

Project No. 0410.20002
 Sheet No. G-44
 of TOT


Project No. 0410.20002

WASHINGTON STREET

MRB group


Engineering, Architecture & Surveying, D.P.C.
 The Culver Road Armory, 145 Culver Road,
 Suite 160, Rochester, New York 14620
 Phone: 585-381-9250
 www.mrbgroup.com

Project No. 0410.20002
 Sheet No. G-44
 of TOT

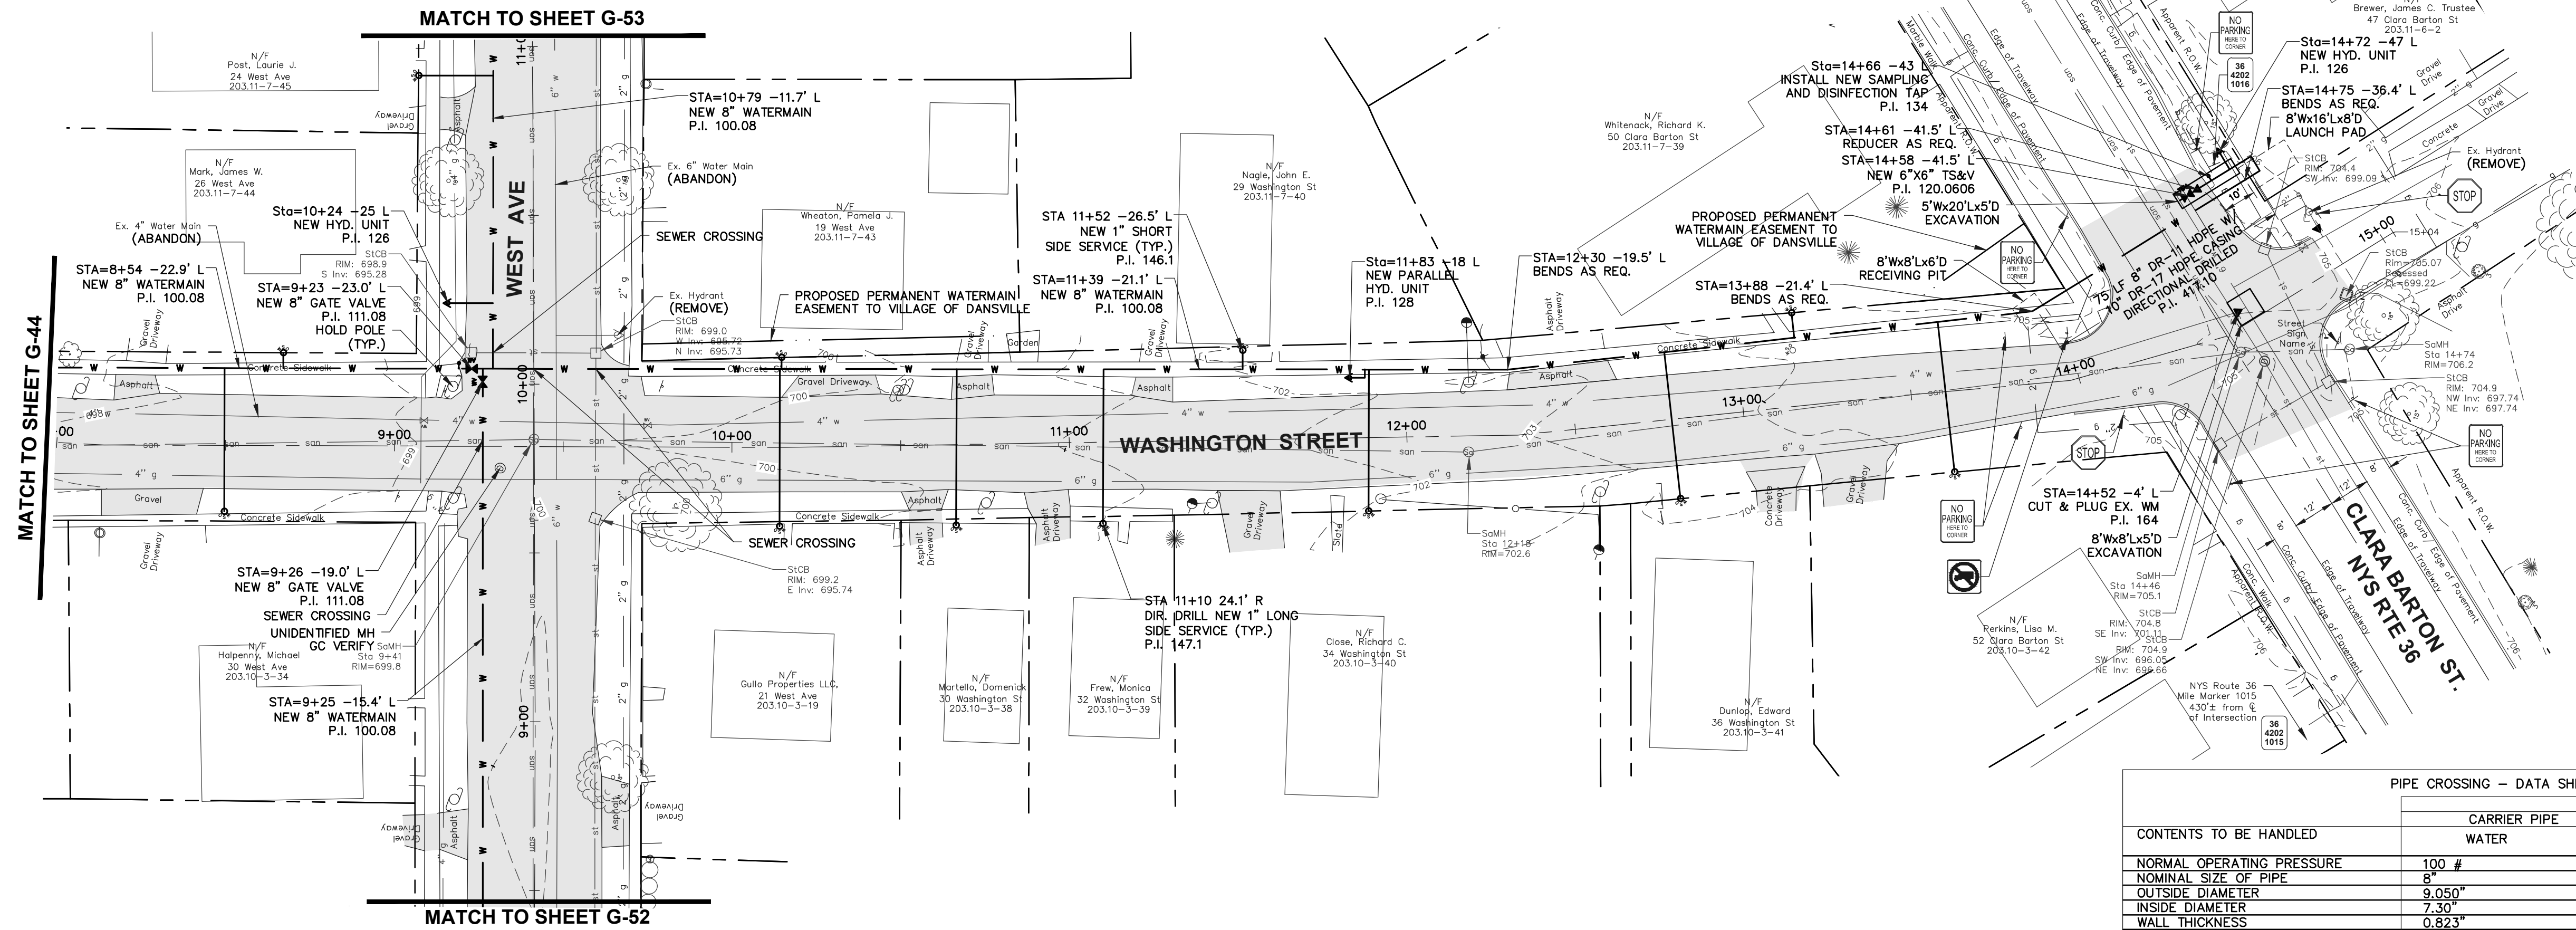

PIPE CROSSING - DATA SHEET

CONTENTS TO BE HANDLED	PIPE DATA	
	CARRIER PIPE	CASING PIPE
WATER		
NORMAL OPERATING PRESSURE	100 #	ATMOSPHERIC
NOMINAL SIZE OF PIPE	8"	10"
OUTSIDE DIAMETER	9.050"	11.100"
INSIDE DIAMETER	7.30"	9.71"
WALL THICKNESS	0.823"	0.853"
WEIGHT PER FOOT	9.32#	9.41#
MATERIAL	HIGH DENSITY POLYETHYLENE	HIGH DENSITY POLYETHYLENE
PROCESS OF MANUFACTURE	EXTRUSION	EXTRUSION
SPECIFICATION	AWWA C906-99	AWWA C906-99
GRADE OR CLASS	DR-11	DR-17
TEST PRESSURE	150 PSI	0
TYPE OF JOINT	BUT FUSION	BUT FUSION
TYPE OF COATING	NONE	NONE
DETAILS OF CATHODIC PROTECTION	NONE	NONE
DETAILS OF SEAL OR PROTECTION	N.A.	N.A.
AT ENDS OF CASING		
METHOD OF INSTALLATION	DIRECTIONALLY DRILLED	DIRECTIONALLY DRILLED

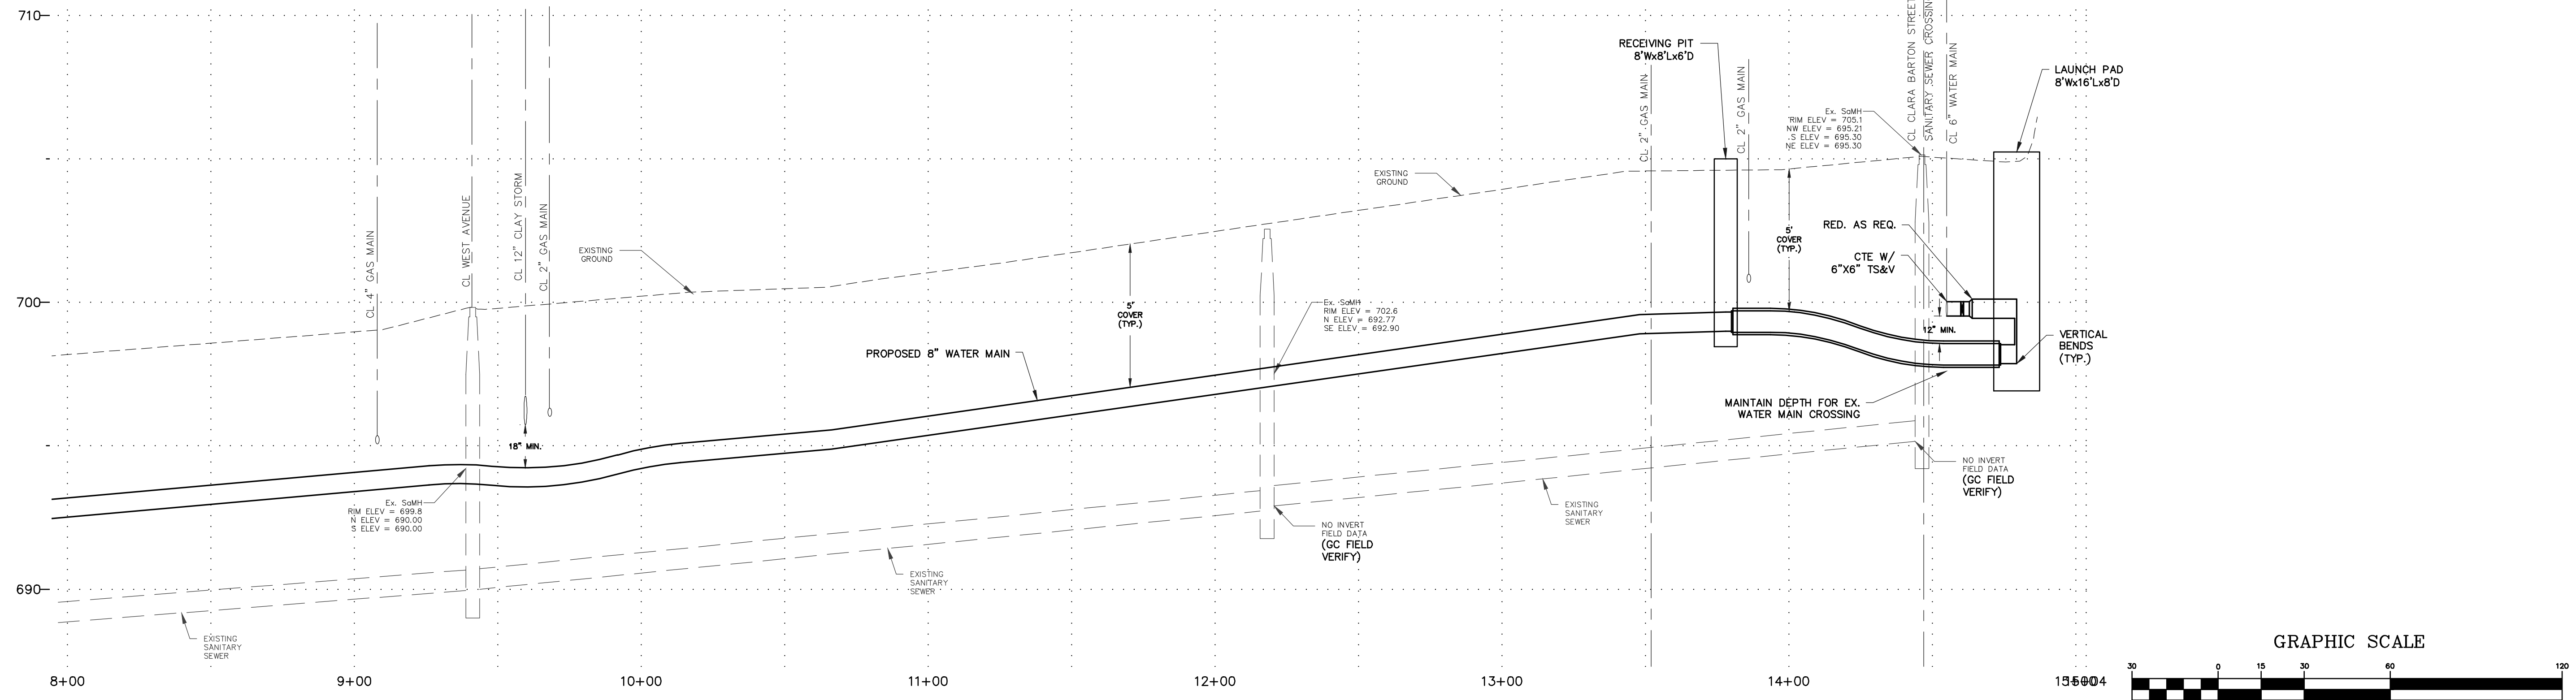

AS ISSUED FOR PRELIMINARY REVIEW

Project Title:	VILLAGE WATER SYSTEM IMPROVEMENT PROJECT 2020 VILLAGE OF DANSVILLE LIVINGSTON COUNTY, NEW YORK	
Drawn By:	BJJ	
Checked By:	GJH	
Scale:	AS SHOWN	
Date:	1/2021	
Drawing Title:	PLAN AND PROFILE	
1. ISSUED FOR INYSDOH REVIEW	DAH	4/29/21
No. Revisions and Descriptions		
Copyright © 2021 MRB Group All Rights Reserved		

Project Title: VILLAGE WATER SYSTEM IMPROVEMENT PROJECT 2020 VILLAGE OF DANSVILLE LIVINGSTON COUNTY, NEW YORK
 Drawn By: BJJ
 Checked By: GJH
 Scale: AS SHOWN
 Date: 1/2021
 Drawing Title: PLAN AND PROFILE

Project Title: VILLAGE WATER SYSTEM IMPROVEMENT PROJECT 2020 VILLAGE OF DANSVILLE LIVINGSTON COUNTY, NEW YORK
 Drawn By: BJJ
 Checked By: GJH
 Scale: AS SHOWN
 Date: 1/2021
 Drawing Title: PLAN AND PROFILE

MRB group
 Engineering, Architecture & Surveying, D.P.C.
 The Culver Road Armory, 145 Culver Road,
 Suite 160, Rochester, New York 14620
 Phone: 585-381-9250
 www.mrbgroup.com

Sheet No. **G-45**
 of **TOT**
 Project No. **0410.20002**

DRAWING ALTERATION THE FOLLOWING IS AN EXCERPT FROM THE NEW YORK EDUCATION LAW ARTICLE 145 SECTION 7209 AND APPLIES TO THIS DRAWING. IT IS A VIOLATION OF THIS LAW FOR ANY PERSON UNLESS HE IS ACTING UNDER THE DIRECTION OF A LICENSED PROFESSIONAL ENGINEER OR LAND SURVEYOR TO ALTER AN ITEM IN ANY WAY IF AN ITEM BEARING THE SEAL OF AN ENGINEER OR LAND SURVEYOR IS ALTERED. THE ALTERING ENGINEER OR LAND SURVEYOR SHALL AFFIX TO THE ITEM HIS SEAL AND THE NOTATION "ALTERED BY" FOLLOWED BY HIS SIGNATURE AND THE DATE OF SUCH ALTERATION AND A SPECIFIC DESCRIPTION OF THE ALTERATION.